


会 审	建 筑	电 源	通 电
Confirmed by	Architecture	Wiring	Electricity
	Structure	给排水	明 电
		Plumbing	BLV

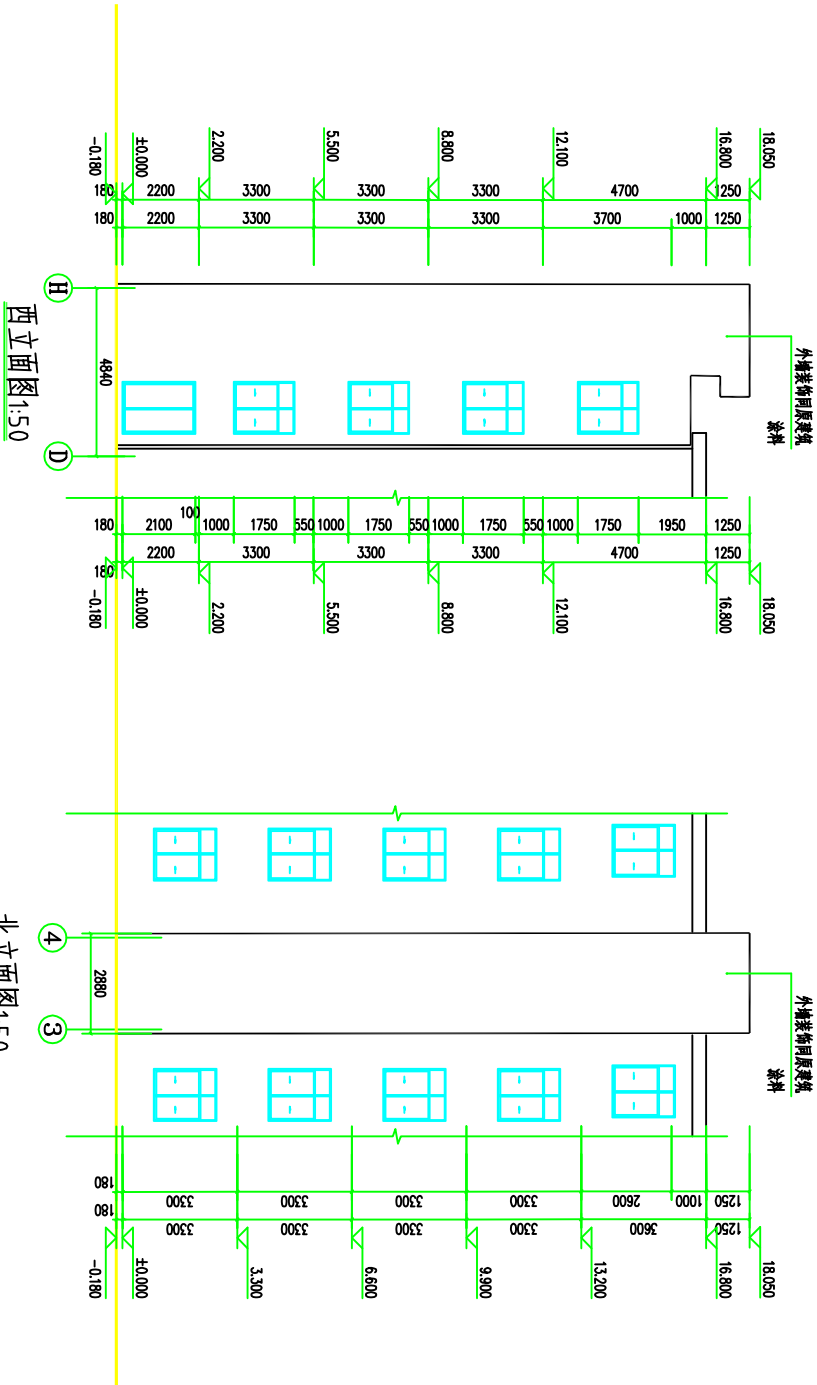

修改记录 modify record	设计单位 Design Institute  浙江新时代建筑设计有限公司 Zhejiang New Era Architectural Design Co., Ltd
设计单位 Design 浙江新时代建筑设计有限公司 Zhejiang New Era Architectural Design Co., Ltd	设计证书编号 (甲级) A1530122871
设计单位 Design 浙江新时代建筑设计有限公司 Zhejiang New Era Architectural Design Co., Ltd	浙江新时代建筑设计有限公司 Zhejiang New Era Architectural Design Co., Ltd
项目名称 Project 新建工作区维修工程加建电梯 New building work area repair project adding elevator	工程名称 Project Name 新建工作区维修工程加建电梯 New building work area repair project adding elevator
工程编号 Project No. 2019.12.2	日期 Date 2019.12.2
项目负责人 The project leader 钟敏洁 Zhong Minjie	项目负责人 The project leader 钟敏洁 Zhong Minjie
专业负责人 Specialty supervisor 钟敏洁 Zhong Minjie	专业负责人 Specialty supervisor 钟敏洁 Zhong Minjie
设计 Design 钟敏洁 Zhong Minjie	设计 Design 钟敏洁 Zhong Minjie
绘图 Drawing 钟敏洁 Zhong Minjie	绘图 Drawing 钟敏洁 Zhong Minjie
校对 Check 钟敏洁 Zhong Minjie	校对 Check 钟敏洁 Zhong Minjie
审核 Review 钟敏洁 Zhong Minjie	审核 Review 钟敏洁 Zhong Minjie
审定 Approval 钟敏洁 Zhong Minjie	审定 Approval 钟敏洁 Zhong Minjie
图样名称 Sheet Title 西立面图 北立面图 West Elevation North Elevation	图样名称 Sheet Title 西立面图 北立面图 West Elevation North Elevation
专业 Specialty 建筑 Architecture	阶段 Phase 施工 Construction
图号 Sheet No. 07	图次 Sheet No. 01
专业负责人签章 Specialty supervisor signature 钟敏洁 Zhong Minjie	专业负责人签章 Specialty supervisor signature 钟敏洁 Zhong Minjie
出图章 Stamp 钟敏洁 Zhong Minjie	出图章 Stamp 钟敏洁 Zhong Minjie
执业章 Professional seal 钟敏洁 Zhong Minjie	执业章 Professional seal 钟敏洁 Zhong Minjie
本图经加建出图章、审核一律无效 This drawing is invalid without the added drawing stamp and review. Issued: Unreviewed (Stamped)	本图经加建出图章、审核一律无效 This drawing is invalid without the added drawing stamp and review. Issued: Unreviewed (Stamped)